


INDEX TO DRAWINGS		
SHEET NO.	SHEET I.D.	SHEET TITLE
1	G001	COVER SHEET
2	G002	INDEX OF DRAWINGS SUMMARY OF APPROXIMATE QUANTITIES AND SHEET CUT LAYOUT
3	G003	GENERAL NOTES AND ABBREVIATIONS
4	G004	SURVEY CONTROL PLAN
5	G005	SAFETY PLAN
6	G006	CONSTRUCTION SAFETY PLAN OVERALL PHASING
7	G050	GEOTECHNICAL BORE PLAN AND LOGS
8	G051	GEOTECHNICAL BORE PLAN AND LOGS
9	C100	DEMOLITION PLAN STA. 8+50 TO STA. 22+00 RUNWAY 17/35
10	C101	DEMOLITION PLAN STA. 22+00 TO STA. 35+50 RUNWAY 17/35
11	C102	DEMOLITION PLAN STA. 35+50 TO STA. 49+00 RUNWAY 17/35
12	C103	DEMOLITION PLAN STA. 49+00 TO STA. 55+75 RUNWAY 17/35 & TAXIWAYS A1 & A2
13	C200	GEOMETRIC LAYOUT PLAN STA. 8+50 TO STA. 22+00 RUNWAY 17/35
14	C201	GEOMETRIC LAYOUT PLAN STA. 22+00 TO STA. 35+50 RUNWAY 17/35
15	C202	GEOMETRIC LAYOUT PLAN STA. 35+50 TO STA. 49+00 RUNWAY 17/35
16	C203	GEOMETRIC LAYOUT PLAN STA. 49+00 TO STA. 55+75 RUNWAY 17/35 & TAXIWAYS A1 & A2
17	C300	GRADING PLAN STA. 8+50 TO STA. 22+00 RUNWAY 17/35
18	C301	GRADING PLAN STA. 22+00 TO STA. 35+50 RUNWAY 17/35
19	C302	GRADING PLAN STA. 35+50 TO STA. 49+00 RUNWAY 17/35
20	C303	GRADING PLAN STA. 49+00 TO STA. 55+75 RUNWAY 17/35 & TAXIWAYS A1 & A2
21	C400	STORM SEWER PLAN AND PROFILE STORM LINE A
22	C500	PLAN AND PROFILE STA. 8+50 TO STA. 21+00 RUNWAY 17/35
23	C501	PLAN AND PROFILE STA. 21+00 TO STA. 33+50 RUNWAY 17/35
24	C502	PLAN AND PROFILE STA. 33+50 TO STA. 46+00 RUNWAY 17/35
25	C503	PLAN AND PROFILE STA. 46+00 TO STA. 55+50 RUNWAY 17/35
26	C504	PLAN AND PROFILE TAXIWAYS A1 & A2
27	C550	RUNWAY 17/35 TYPICAL SECTIONS
28	C600	PAVEMENT MARKING PLAN STA. 8+50 TO STA. 22+00 RUNWAY 17/35
29	C601	PAVEMENT MARKING PLAN STA. 22+00 TO STA. 35+50 RUNWAY 17/35
30	C602	PAVEMENT MARKING PLAN STA. 35+50 TO STA. 49+00 RUNWAY 17/35
31	C603	PAVEMENT MARKING PLAN STA. 49+00 TO STA. 55+75 RUNWAY 17/35 & TAXIWAYS A1 & A2
32	C650	PAVEMENT MARKING DETAILS
33	C700	EROSION CONTROL PLAN STA. 8+50 TO STA. 22+00 RUNWAY 17/35
34	C701	EROSION CONTROL PLAN STA. 22+00 TO STA. 35+50 RUNWAY 17/35
35	C702	EROSION CONTROL PLAN STA. 35+50 TO STA. 49+00 RUNWAY 17/35
36	C703	EROSION CONTROL PLAN STA. 49+00 TO STA. 55+75 RUNWAY 17/35 & TAXIWAYS A1 & A2
37	C750	EROSION CONTROL DETAILS
38	E100	ELECTRICAL LAYOUT PLAN STA. 8+50 TO STA. 22+00 RUNWAY 17/35
39	E101	ELECTRICAL LAYOUT PLAN STA. 22+00 TO STA. 35+50 RUNWAY 17/35
40	E102	ELECTRICAL LAYOUT PLAN STA. 35+50 TO STA. 49+00 RUNWAY 17/35
41	E103	ELECTRICAL LAYOUT PLAN STA. 49+00 TO STA. 55+75 RUNWAY 17/35 & TAXIWAYS A1 & A2
42	E150	ELECTRICAL DETAILS
43	E151	ELECTRICAL DETAILS

SUMMARY OF APPROXIMATE QUANTITIES				
ITEM NO.	ITEM DESCRIPTION	UNIT	SCHEDULE I	
			ESTIMATE	AS-BUILT
GP-105a	MOBILIZATION	LS	1	
KDOT 201a	CLEARING AND GRUBBING	AC	9	
KDOT 202a	REMOVAL OF EXISTING STRUCTURES	LS	1	
KDOT 205a	COMMON EXCAVATION (UNSTABLE)	CY	2,200	
KDOT 205b	EMBANKMENT (CONTRACTOR-FURNISHED)	CY	4,270	
KDOT 303a	FLY ASH	TON	475	
KDOT 303b	MANIPULATION FOR TREATED SUBGRADE (FLY ASH)	SY	6,600	
KDOT 303c	WATER (TREATED SUBGRADE) (SET PRICE)	M GALLON	1	
KDOT 602a	HMA SURFACE (SR-12.5A)(PG64-22)	TON	6,110	
KDOT 602b	TACK COAT	GAL	2,720	
KDOT 612a	MILLING	SY	26,330	
KDOT 612b	PLACEMENT OF MILLINGS (4")	SY	26,890	
KDOT 817a	STORM SEWER (14"x23") (HERCP)	LF	59	
KDOT 817b	END SECTION (14"x23") (HERCP)	EA	2	
KDOT 902a	TEMPORARY EROSION AND SEDIMENT CONTROL	LS	1	
KDOT 904a	SEED (HYDRO) (BUFFALOGRASS - SHARP'S IMPROVED)	AC	9	
KDOT 906a	TOPSOIL (3")	CY	3,610	
P-620a	TEMPORARY PAVEMENT MARKINGS	SF	5,225	
P-620b	PERMANENT PAVEMENT MARKINGS	SF	5,225	
L-108a	L-824C #8 AWG 5000V WIRE	LF	600	
L-108b	#6 AWG BARE COUNTERPOISE WIRE	LF	600	
L-110a	INSTALL 1-2" SCH. 40 PVC CONDUIT (DEB)	LF	600	
L-125a	ADJUST RUNWAY EDGE LIGHT	EA	44	
L-125b	RELOCATE RUNWAY THRESHOLD LIGHT	EA	12	
L-125c	RELOCATE TAXIWAY EDGE LIGHT	EA	14	
L-125d	ADJUST TAXIWAY EDGE LIGHT	EA	2	

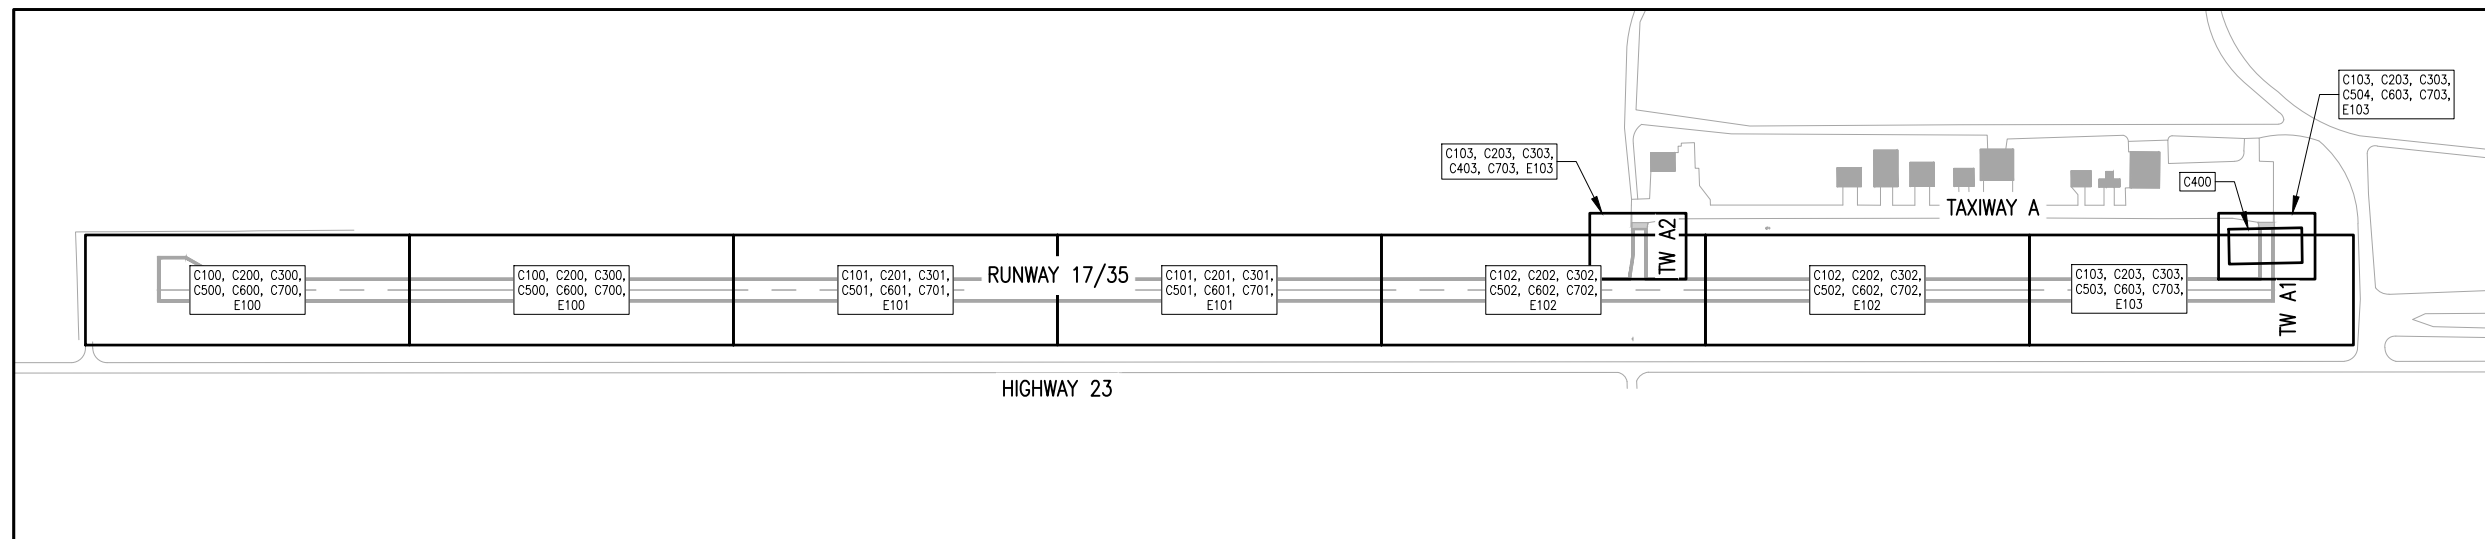

**ISSUE FOR BID**

THESE DRAWINGS ARE FOR BIDDING PURPOSES ONLY. THEY WERE PREPARED BY OR UNDER THE SUPERVISION OF:

BRIAN LINCOLN      24373      7/16/18  
NAME      REG. NO.      DATE  
FOR AND ON BEHALF OF JVIATION, INC.

L:\155\155 - Record\CD\155.dwg

D:\155-155-RW-REBID-2002-155.dwg  
Jul 13, 2018 - 11:47am  
daron@jviation.com



**HOXIE-SHERIDAN  
COUNTY AIRPORT  
HOXIE, KS**

DES: J.H.M.	ISSUE RECORD			
	NO.	BY	DATE	DESCRIPTION
DR: B.S.C.	1	B.T.L.	7/16/18	ISSUED FOR BID
CH: C.L.G.				
APP: B.T.L.				

**RUNWAY 17/35  
RECONSTRUCTION**

**INDEX OF DRAWINGS  
SUMMARY OF APPROXIMATE QUANTITIES  
AND SHEET CUT LAYOUT**

KDOT PROJ. NO. AV-2015-07	JVIATION PROJ. NO. 2014.1F5.01	DATE: 7/16/18
------------------------------	-----------------------------------	------------------

SHEET NAME  
G002  
SHEET NO.  
2 of 43